

NOTES

- EXISTING ENTRANCES TO PROPERTIES TO BE KEPT LIVE AT ALL TIMES FOR THE DURATION OF WORKS
- ONE TRAFFIC LANE TO BE OPEN AT ALL TIMES. TRAFFIC MANAGEMENT PLAN TO BE UNDERTAKEN IN ACCORDANCE WITH CHAPTER 8 OF THE TRAFFIC SIGNS MANUAL AND PUNCH SITEWORKS SPECIFICATION. TRAFFIC MANAGEMENT PLAN TO BE AGREED WITH TIPPERARY COUNTY COUNCIL PRIOR TO COMMENCEMENT ON SITE.
- TOPOGRAPHICAL SURVEY CARRIED OUT BY SCANTECH GEOSCIENCE.
- REFER TO SERVICE PROVIDER RECORD DRAWINGS FOR DETAILS OF EXISTING SERVICES TO BE REVIEWS IN CONJUNCTION WITH SCANTECH GEOSCIENCE SURVEYS GPR DRAWINGS 2640.
- REFER TO SERVICE REFER TO JB BARRY DRAWING Y15706_C_024/024-1035/050/115 AND WALSH CIVIL ENGINEERING DRAWINGS NENAGH-SR-108/109 (AS-BUILT SEWER) FOR DETAILS OF FOUL SEWER CONSTRUCTED UNDER A SEPARATE CONTRACT. CONTRACTOR TO SURVEY LOCATION/ CENTERLINE/ INVERT LINE OF 900mm SEWER AND SUBMIT TO ENGINEER 5 WORKING DAYS PRIOR TO COMMENCEMENT ON SITE.
- REFER TO SERVICE PROVIDER RECORD DRAWINGS FOR DETAILS OF EXISTING SERVICES TO BE REVIEWS IN CONJUNCTION WITH SCANTECH GEOSCIENCE SURVEYS GPR DRAWINGS 2640.
- ALL LEVELS ARE IN METERS ABOVE MALIN HEAD DATUM AS DERIVED ON TOPOGRAPHICAL SURVEY.
- THIS DRAWING SHOULD BE READ IN CONJUNCTION WITH ALL RELEVANT EMPLOYERS REPRESENTATIVE AND MANUFACTURERS' DRAWINGS AND SPECIFICATIONS.
- THE CONTRACTOR MUST CONTACT THE RELEVANT AUTHORITIES PRIOR TO CONSTRUCTION WORK, AND SATISFY HIMSELF IN RESPECT TO THE LOCATION OF ALL EXISTING SERVICES.
- CONTRACTOR TO PROVIDE IL PIPE DIAMETER AND DIRECTION OF FLOW IN EXISTING MANHOLES ON COMMENCEMENT OF THE WORKS TO THE EMPLOYERS REPRESENTATIVE
- CLASS S BEDDING TO BE PROVIDED WHERE MINIMUM COVER TO PIPES = 1200mm OR GREATER
- CLASS Z BEDDING TO BE PROVIDED WHERE MINIMUM COVER TO PIPES = 800mm AND LESS THAN 1200mm
- ALL TEMPORARY WORKS TO CONTRACTORS DESIGN
- DRAWING TO BE READ IN CONJUNCTION WITH ALL GPR/ TOPOGRAPHIC SURVEYS AND SITE INVESTIGATION REPORT.
- IDENTIFICATION AND LOCATION OF ALL SERVICE TO BE CONFIRMED BY THE CONTRACTOR PRIOR TO COMMENCEMENT ON SITE.
- ALL KERBS DAMAGED DURING THE WORKS TO BE REPAIRED BY CONTRACTOR AT THEIR OWN EXPENSE
- ALL EXISTING GULLIES WITHIN THE SITE EXTENTS TO BE JETTED AND CLEANED OUT



THE CONTRACTOR IS ADVISED TO REFER TO THE RELEVANT GPR AND EXISTING INFORMATION DRAWINGS PROVIDED AS PART OF THE TENDER DOCUMENTS.

EXISTING SERVICE INFORMATION (IF SHOWN) IS FROM RECORDS AND GPR IS NOT EXHAUSTIVE. OTHER SERVICES MAY BE ENCOUNTERED ON SITE

EXISTING SERVICES AS INDICATED ARE BASED OFF SERVICE PROVIDER DRAWINGS/ SCANTECH GEOSCIENCE TOPOGRAPHIC AND GPR SURVEY/ AS-BUILT SURVEY INFORMATION FROM JB BARRY&WALSHE CIVIL ENGINEERING. PLEASE REFER TO THE ADDITIONAL INFORMATION PACK INCLUDED WITH THE TENDER PACK.

THE CONTRACTOR IS TO REFER TO DRAWING 161-266-033 FOR PIPE BACKFILL AND TRENCH REINSTATEMENT ABOVE THE PIPE BEDDING SURROUND

NOTE :
 CONTRACTOR TO NOTE - HALF CARRIAGEWAY WIDTH SURFACING REINSTATEMENT A REQUIREMENT FOR THIS CONTRACT. ALL REINSTATEMENT TO MATCH EXISTING LEVELS

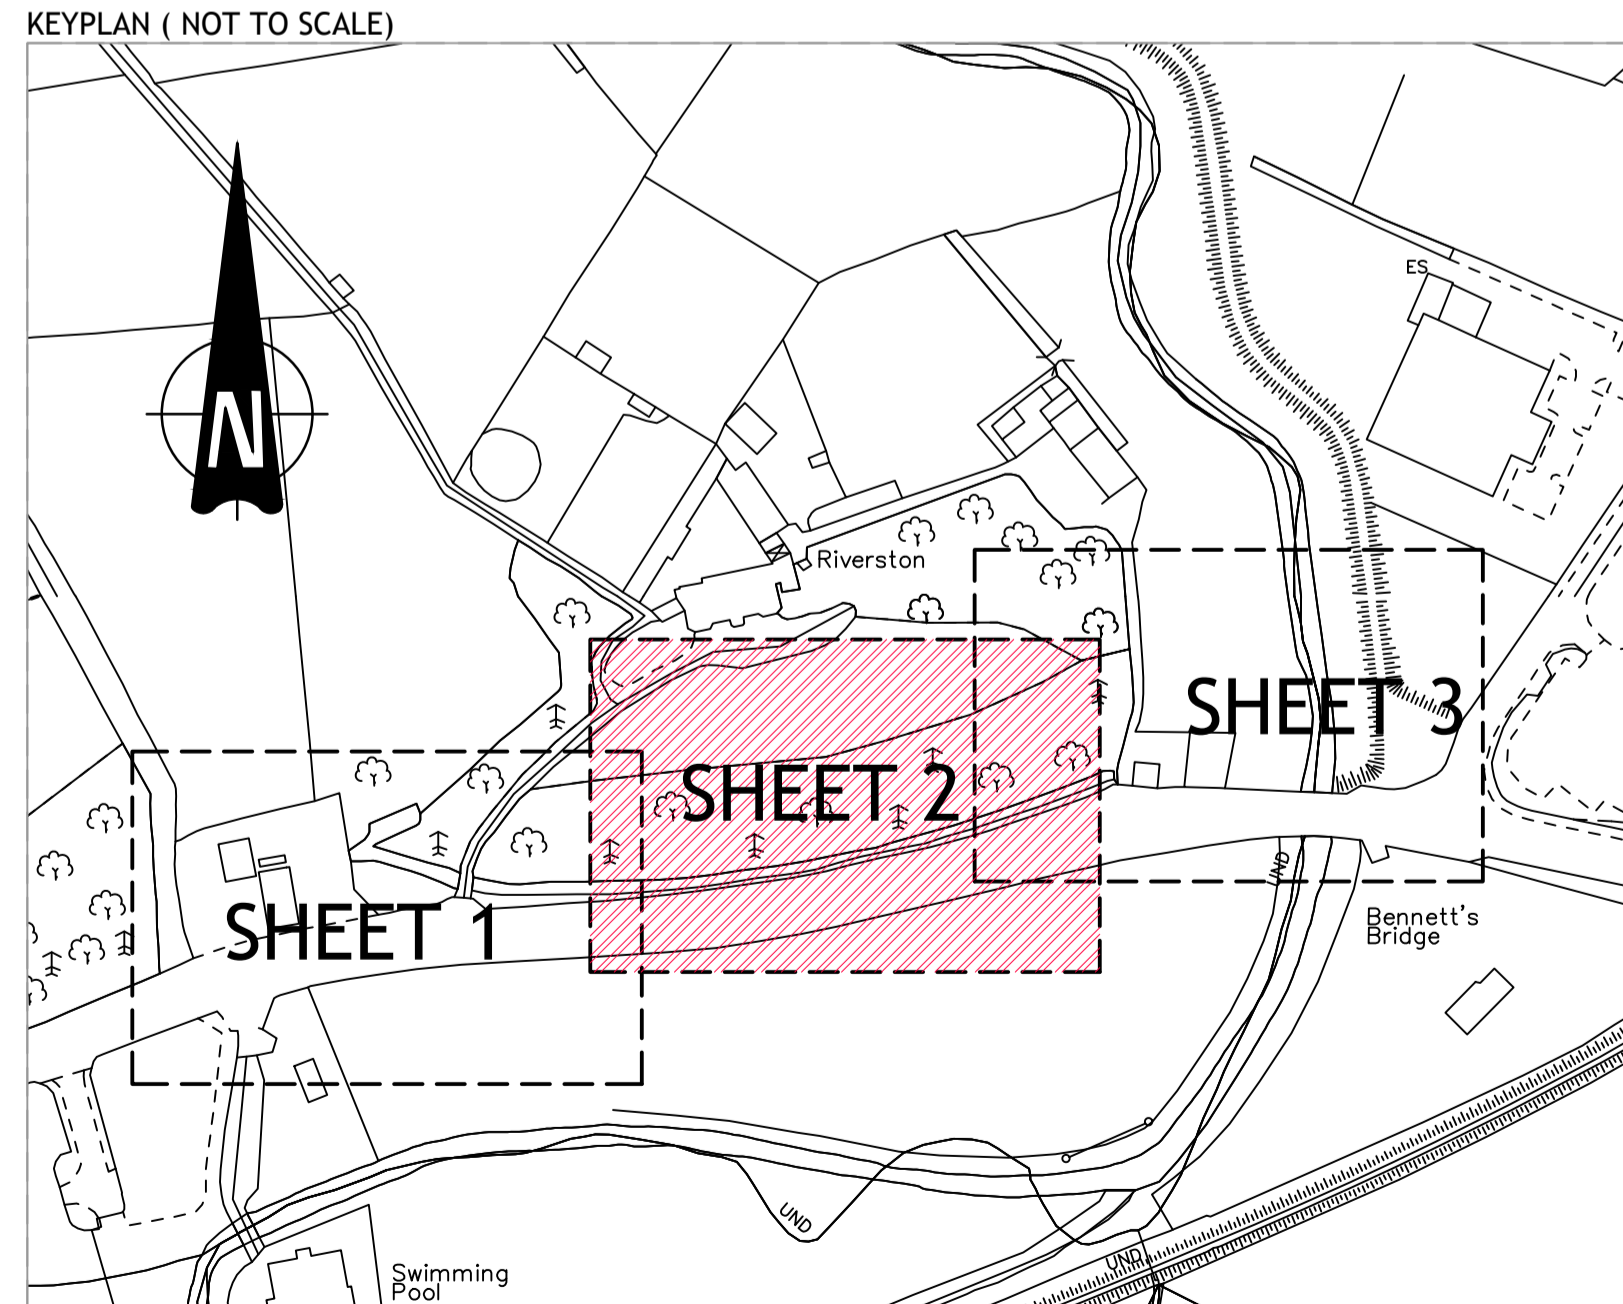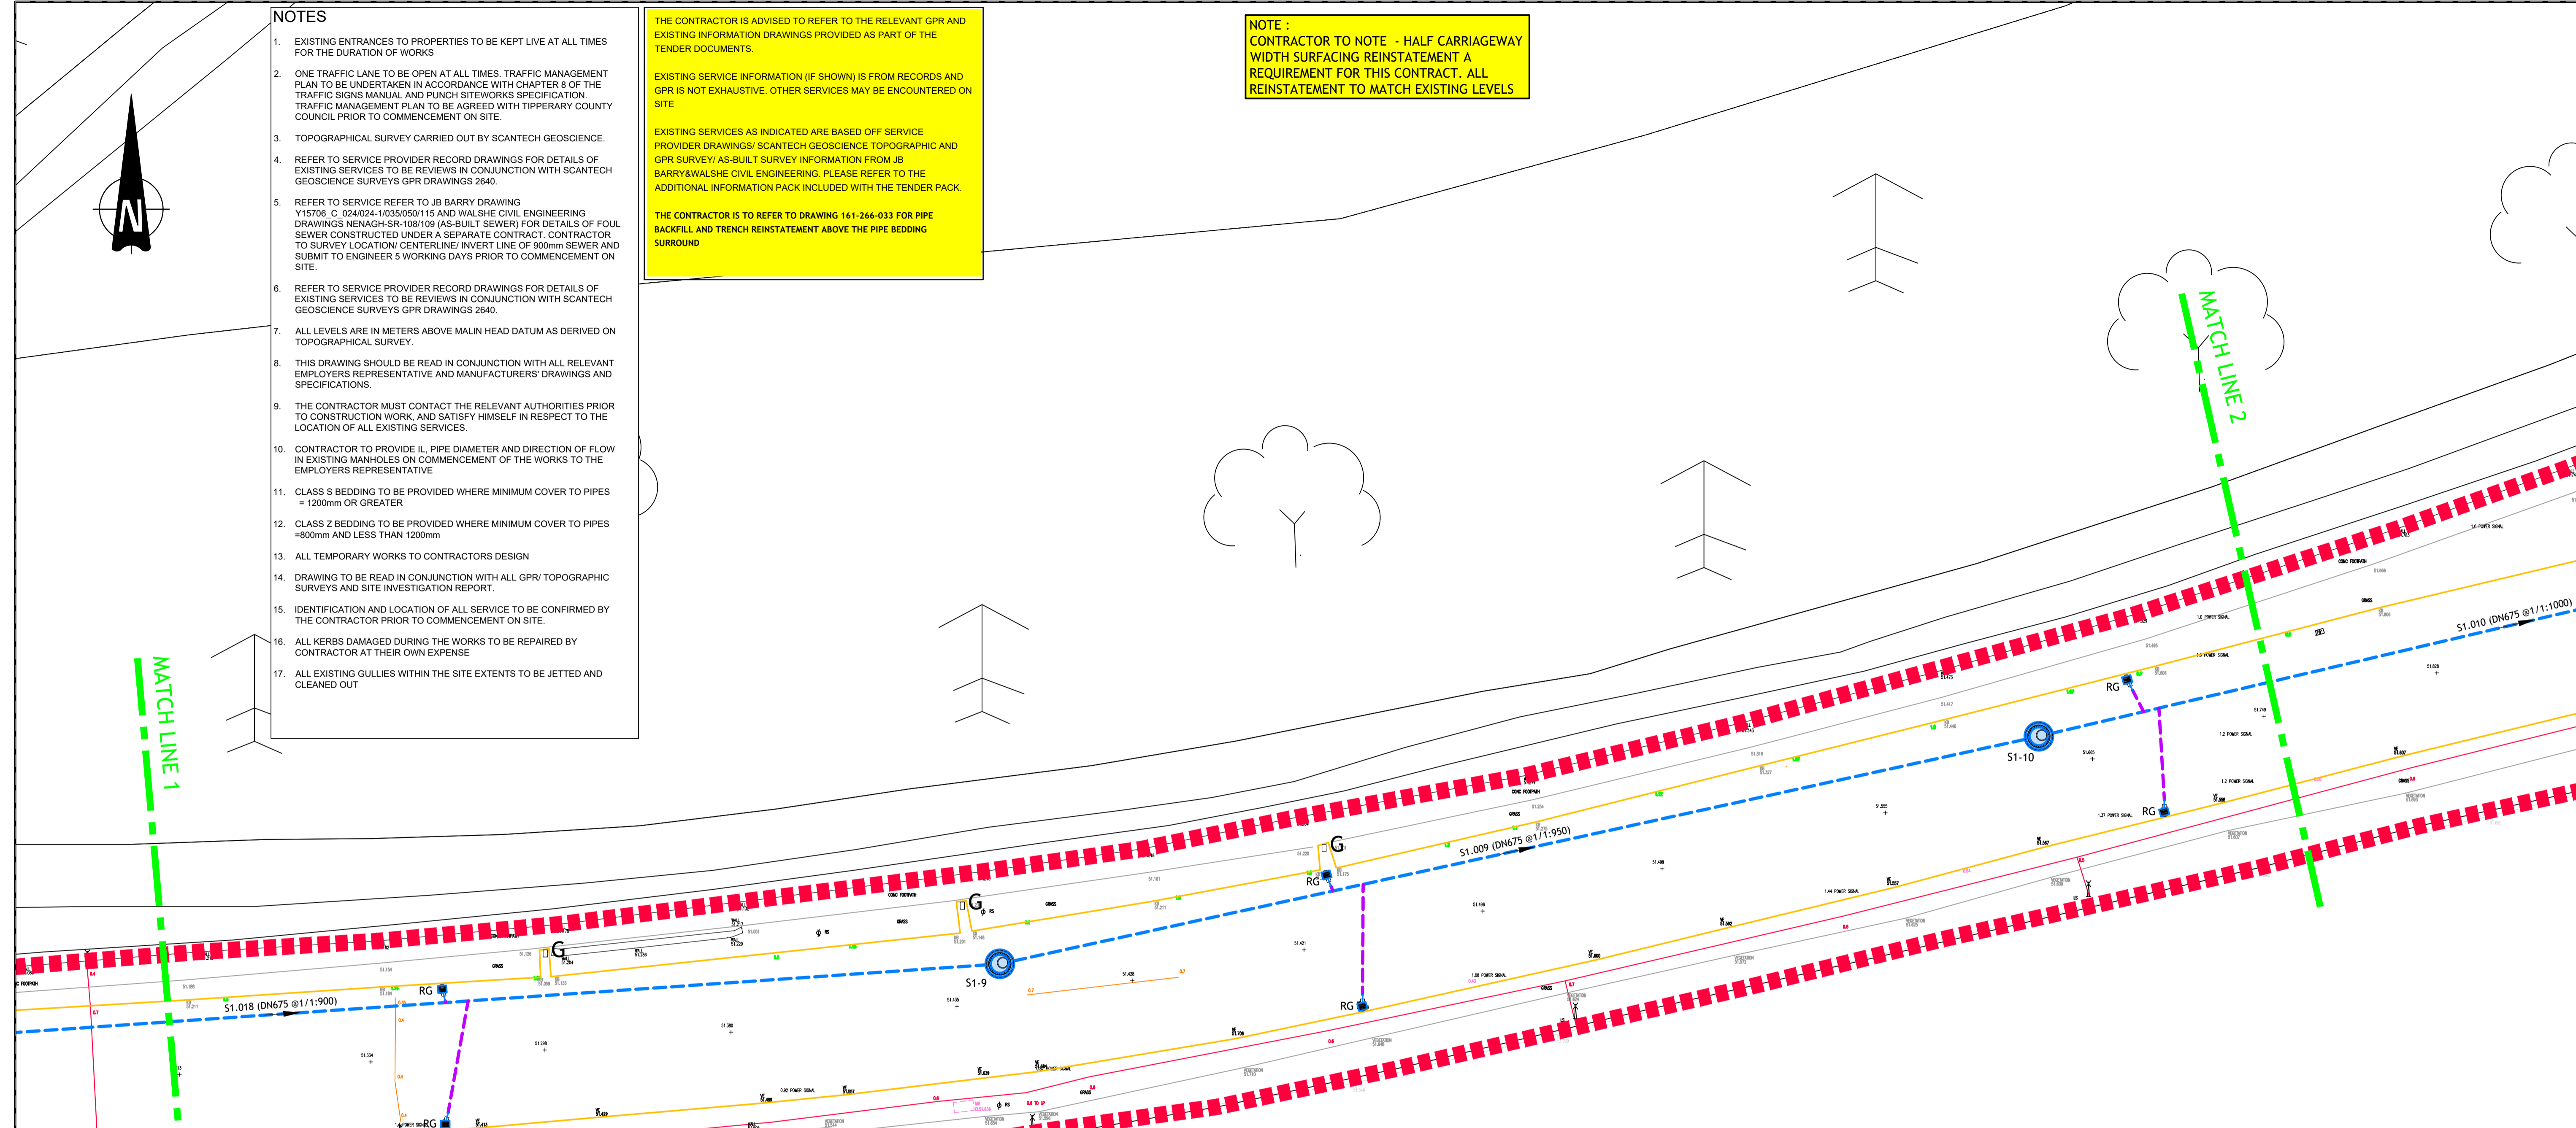

DRAINAGE LEGEND

PHASE 2 CONTRACT - PROPOSED STORM SEWER	
PHASE 2 CONTRACT - PROPOSED HIPPO STYLE GULLY POT WITH 150mm CONNECTION	
EXISTING STORM SEWER - LAID UNDER PREVIOUS CONTRACT	
EXISTING HIPPO STYLE GULLY POT WITH 150mm CONNECTION - LAID UNDER PREVIOUS CONTRACT	
ROAD EXTENTS	
EXISTING GULLY	
EXISTING 350mm ASBESTOS WATERMAIN CONTRACTOR TO PROVIDE METHOD STATEMENT PRIOR TO WM CROSSING	
SITE BOUNDARY	

Ordnance Survey Ireland Licence No EN 0003719
 © Ordnance Survey Ireland/Government of Ireland

© Punch Consulting Engineers

This drawing and any design hereon is the copyright of the Consultants and must not be reproduced without their written consent. All drawings remain the property of the Consultants. Figured dimension only to be taken from this drawing. Consultants to be informed immediately of any discrepancies before work proceeds.

Date Drawn: 2019-05-10
 Drawn By: P.J. Mulcahy
 Date Issued: 2019-07-24
 Issued By: T. Hanley



Rev	Amendment	By	Date
PR1	NOTES REVISED	PJM	2019-05-17
PL0	ISSUED FOR PLANNING	TH	2019-07-24

Client:
 Comhairle Contae Thiobraid Árann
 Tipperary County Council

Job: NENAGH STORM WATER DRAINAGE ASSESSMENT
 Title: DRAINAGE LAYOUT SHEET-2

PUNCH consulting engineers
 Dublin | Limerick | Cork | Galway | Glasgow
 97 Henry Street, Limerick, V94 YC2H
 TEL: +353 61 221 200 www.punchconsulting.com

Stage: PLANNING
 Scale @ A1: 1:200
 Technician Check: P.J. Mulcahy
 Engineer Check: F.TIMLIN
 Approved: D. Gallery
 Drawing No: 161-266-022
 Rev: PL0